
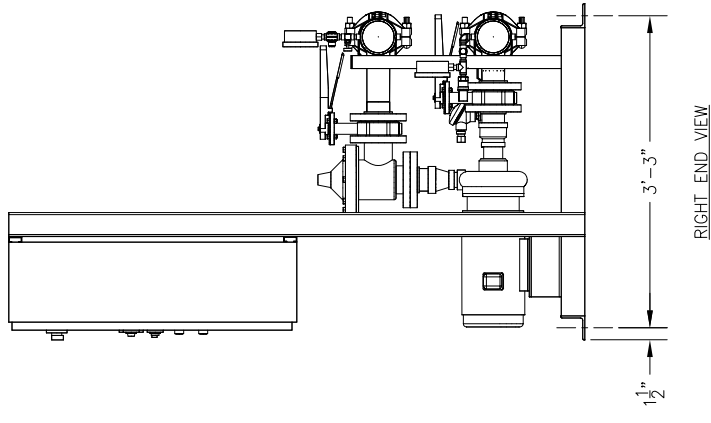
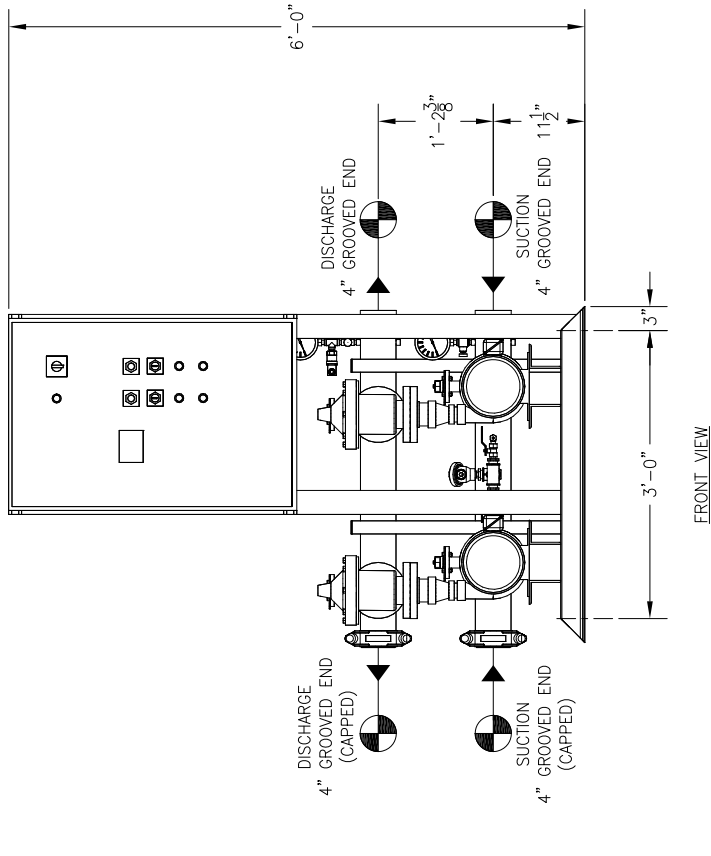
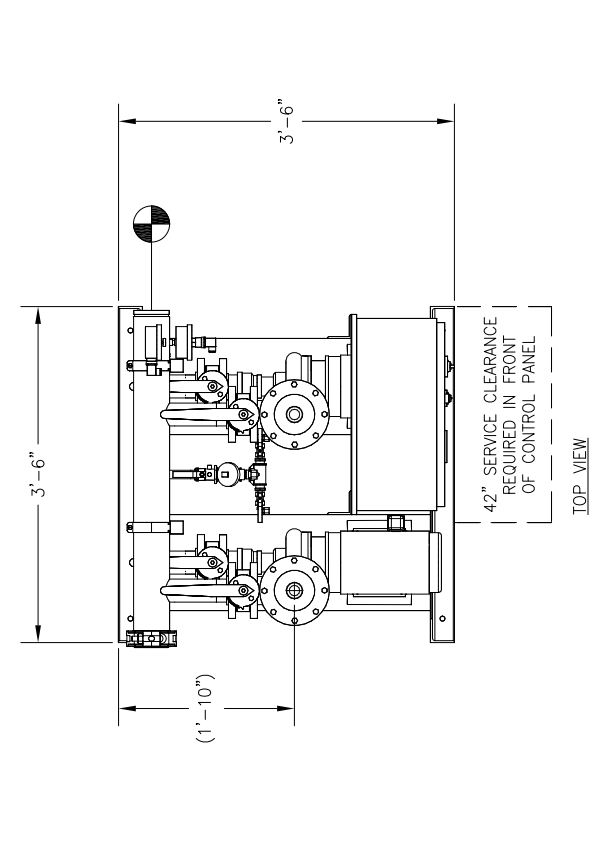


RELIEF VALVES AND EQUIPMENT DRAINS TO BE PIPED TO DRAIN OR VENT BY CONTRACTOR PER CODE REQUIREMENT.

ALL BOLTING AND ANCHORAGE TO BE IN COMPLIANCE WITH LOCAL CODES AND ANY SEISMIC REQUIREMENTS.

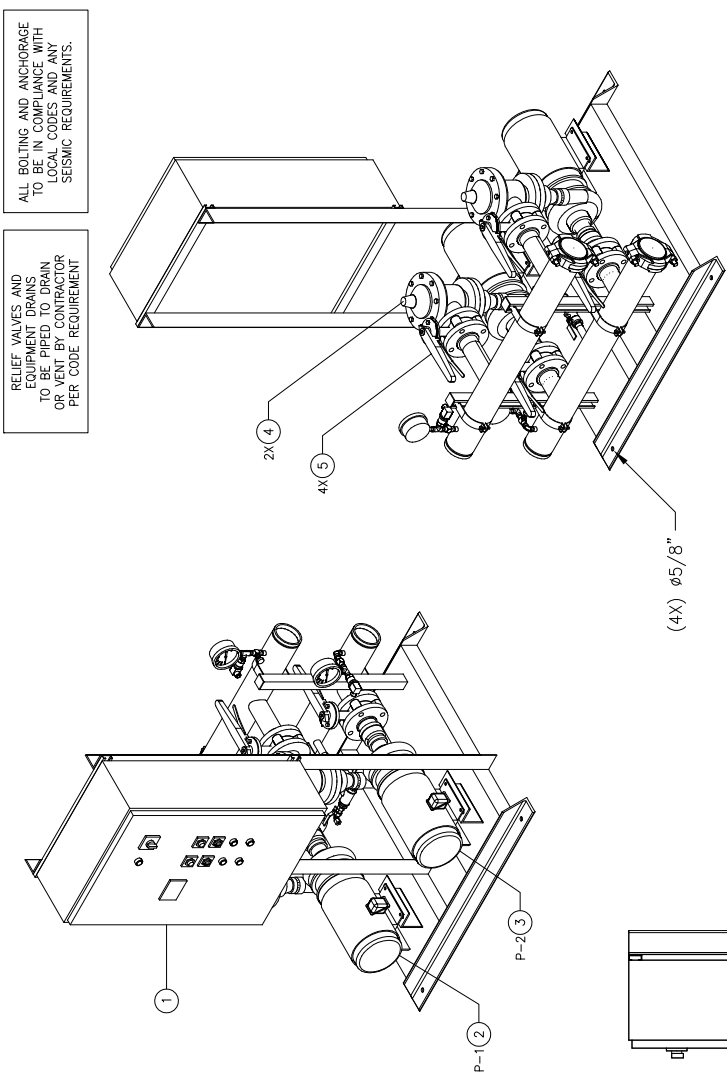

- CONSTRUCTION NOTES:
1. SUCTION AND DISCHARGE HEADERS ARE GROOVED ON BOTH ENDS.
 2. END CAPS CAN BE PLACED ON EITHER END OF HEADERS.
 3. SYSTEM DESIGNED FOR INDOOR INSTALLATION.

GPM		PSI		PSI						
TOTAL FLOW		TOTAL DISCHARGE PRESSURE		AVAILABLE PRESSURE						
TOTAL SYSTEM CAPACITY										
3	P-2	GOULDS	3656	1 1/2 x 2-6	—	5	3500	460 / 60 / 3	TEFC P.E.	
2	P-1	GOULDS	3656	1 1/2 x 2-6	—	5	3500	460 / 60 / 3	TEFC P.E.	
ITEM	TAG	MANUFACTURER	SERIES	MODEL	GPM	TDH	HP	RPM	VOLTS/HZ/PH	ENCLOSURE
PUMP SCHEDULE										

ITEM	QTY	TAG	DESCRIPTION
10	—	—	—
9	—	—	—
8	—	—	—
7	—	—	—
6	—	—	—
5	4	—	LUG TYPE BUTTERFLY VALVE — 2 1/2"
4	2	—	CL-A-VAL CHECK VALVE — 2 1/2"
3	1	P-2	GOULDS 3656 S 1 1/2 X 2-6 BRONZE FITTED END SUCTION CAST IRON PUMP
2	1	P-1	GOULDS 3656 S 1 1/2 X 2-6 BRONZE FITTED END SUCTION CAST IRON PUMP
1	1	—	VARIABLE SPEED PUMP CONTROL PANEL

GENERAL NOTES:

- (1) SINGLE POINT POWER CONNECTION AT CONTROL PANEL.
- (2) HYDRO PRESSURE CHECK AT 125 PSI.
- (3) ASSEMBLED SYSTEM TO BE PAINTED WITH INDUSTRIAL MACHINE ENAMEL PRIOR TO SHIPMENT.

= DENOTES CONTRACTOR POINT OF CONNECTION

LISTED

PACKAGED PUMPING SYSTEMS & HEAT TRANSFER SYSTEMS

UL

APPROXIMATE SHIPPING WEIGHT: 1,028 LBS.

APPROXIMATE OPERATING WEIGHT: 1,094 LBS.

PROJECT NAME:

CUSTOMER:

DRAWN BY DATE: 04/15/16

CHECKED BY: ACD

TOLERANCES UNLESS OTHERWISE SPECIFIED

DEC. .500"

FRAC. 1/2"

ANGLE 5"

SCALE 1" = 1'-0"

FAB No.

DRAWING No.

FEV2-11

REV 1

FlowTHERM systems

HAYWARD, CALIFORNIA

EQUIPMENT SCHEDULE