


RELIEF VALVES AND EQUIPMENT DRAINS TO BE PIPED TO DRAIN OR VENT BY CONTRACTOR PER CODE REQUIREMENT.

ALL BOLTING AND ANCHORAGE TO BE IN COMPLIANCE WITH LOCAL CODES AND ANY SEISMIC REQUIREMENTS.

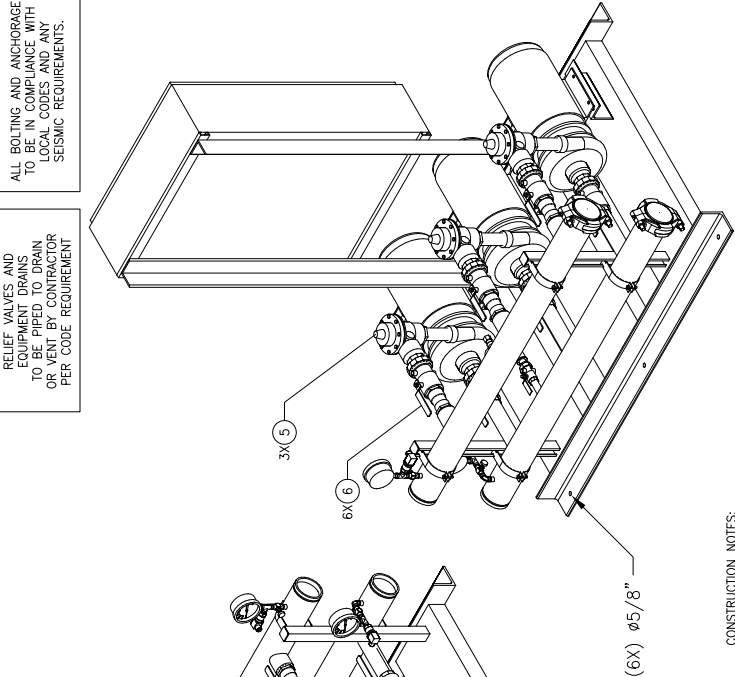

CONSTRUCTION NOTES:

- 1. SUCTION AND DISCHARGE HEADERS ARE GROOVED ON BOTH ENDS.
- 2. END CAPS CAN BE PLACED ON EITHER END OF HEADERS.
- 3. SYSTEM DESIGNED FOR INDOOR INSTALLATION.

-GPM		- PSI		- PSI
TOTAL FLOW		TOTAL DISCHARGE PRESSURE		AVAILABLE PRESSURE
TOTAL SYSTEM CAPACITY				

ITEM	TAG	MANUFACTURER	SERIES	MODEL	GPM	TDH	HP	RPM	VOLTS/4Z/PH	ENCLOSURE
3	P-3	GOULDS	3656	1 1/2 X 2-8	-	-	7 1/2	3500	1460 / 60 / 3	TEFC P.E.
2	P-2	GOULDS	3656	1 1/2 X 2-8	-	-	7 1/2	3500	1460 / 60 / 3	TEFC P.E.
1	P-1	GOULDS	3656	1 1/2 X 2-8	-	-	7 1/2	3500	1460 / 60 / 3	TEFC P.E.

PUMP SCHEDULE

ITEM	QTY	TAG	DESCRIPTION
10	-	-	-
9	-	-	-
8	-	-	-
7	-	-	-
6	6	-	UNION BALL VALVE - 2"
5	3	-	CIA-VAL CHECK VALVE - 2"
4	1	P-3	GOULDS 3656 S 1 1/2 X 2-8 BRONZE FITTED END SUCTION CAST IRON PUMP
3	1	P-2	GOULDS 3656 S 1 1/2 X 2-8 BRONZE FITTED END SUCTION CAST IRON PUMP
2	1	P-1	GOULDS 3656 S 1 1/2 X 2-8 BRONZE FITTED END SUCTION CAST IRON PUMP
1	1	-	VARIABLE SPEED PUMP CONTROL PANEL

EQUIPMENT SCHEDULE

PROJECT NAME:

CUSTOMER:

DRAWN BY DATE: 12/24/14

CHECKED BY APPROVED BY:

TOLERANCES UNLESS OTHERWISE SPECIFIED

DEC. .500"

FRAC. 1/2"

ANGLE 5"

SCALE 1" = 1'-0"

DRAWING TITLE:


FEV3-8 - VARIABLE SPEED TRIPLEX PRESSURE BOOSTER

FAB No.


DRAWING No.

FEV3-8


REV 1

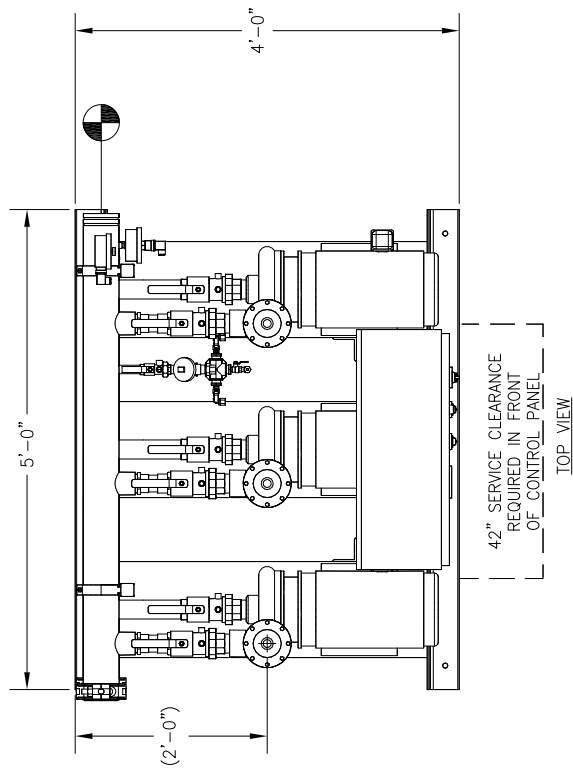

TOP VIEW

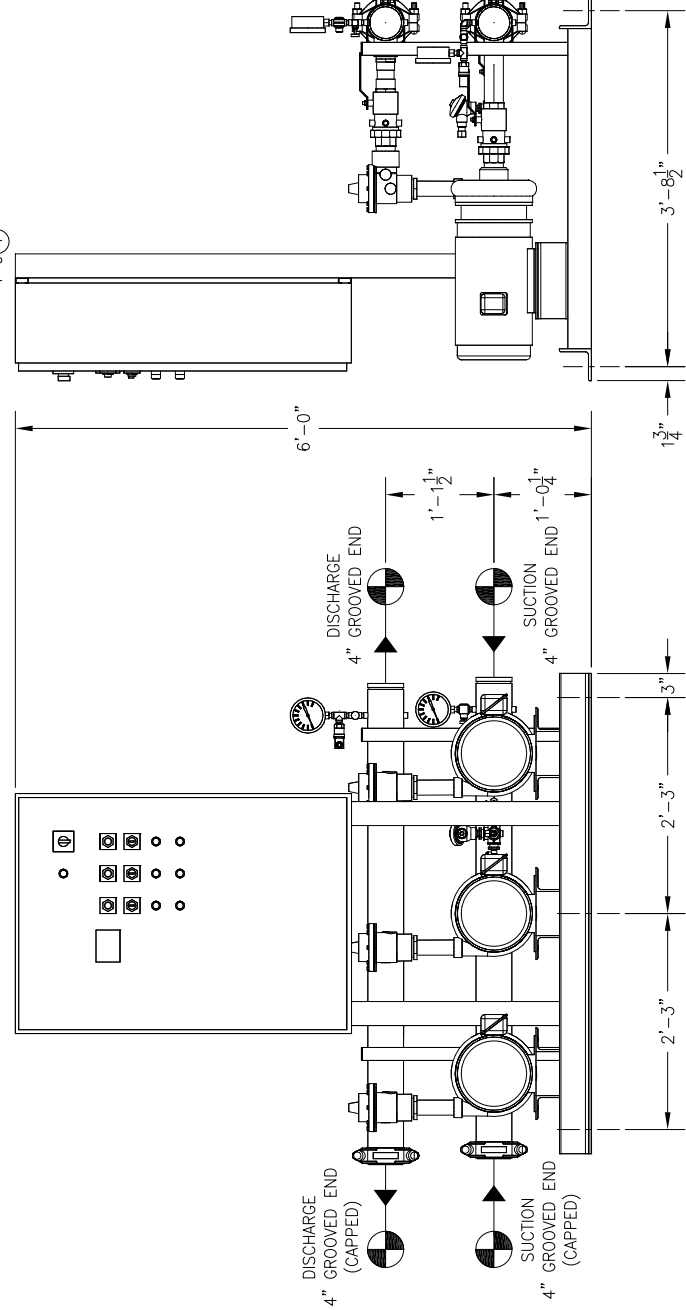

FRONT VIEW

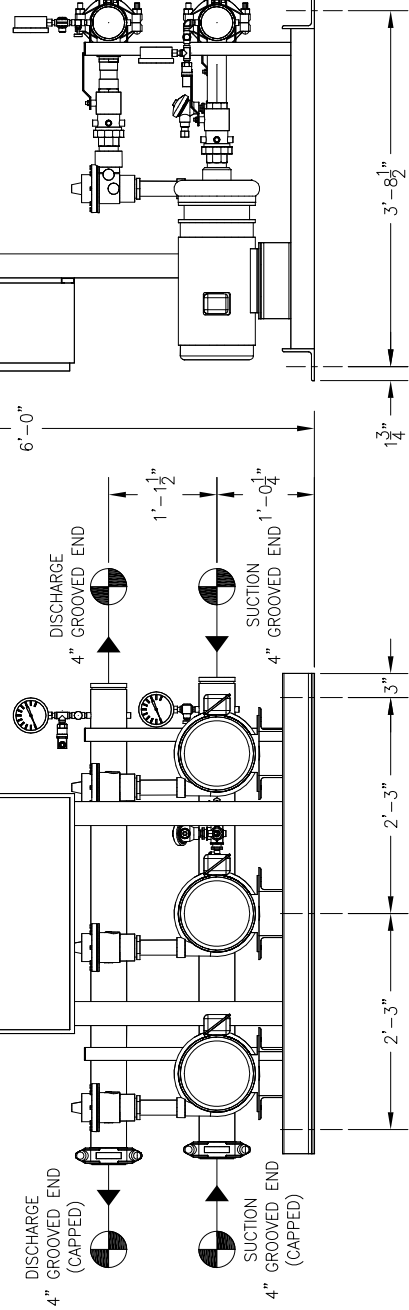

RIGHT END VIEW

GENERAL NOTES:

- (1) SINGLE POINT POWER CONNECTION AT CONTROL PANEL.
- (2) HYDRO PRESSURE CHECK AT 125 PSI.
- (3) ASSEMBLED SYSTEM TO BE PAINTED WITH INDUSTRIAL MACHINE ENAMEL PRIOR TO SHIPMENT.

LISTED

PACKAGED PUMPING SYSTEMS & HEAT TRANSFER SYSTEMS

UL

APPROXIMATE SHIPPING WEIGHT: 1,463 LBS.

APPROXIMATE OPERATING WEIGHT: 1,552 LBS.

= DENOTES CONTRACTOR POINT OF CONNECTION

THIS DRAWING AND THE INFORMATION REPORTED THEREIN ARE THE PROPERTY OF FLOWTHERM SYSTEMS, A DIVISION OF CHC. COPIES ARE ISSUED IN STRICT CONFIDENCE AND SHALL NOT BE REPRODUCED OR TRANSMITTED IN ANY FORM OR BY ANY MEANS, ELECTRONIC OR MECHANICAL, INCLUDING PHOTOCOPYING, RECORDING, OR BY ANY INFORMATION STORAGE AND RETRIEVAL SYSTEM, WITHOUT THE WRITTEN PERMISSION OF CHC.