
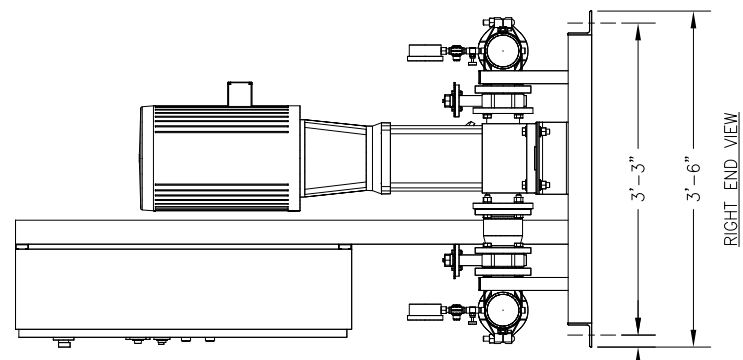
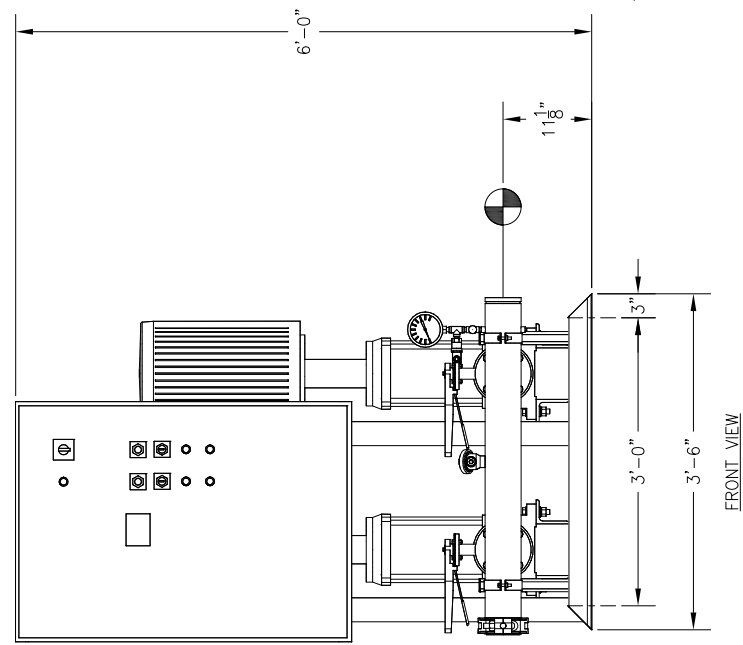
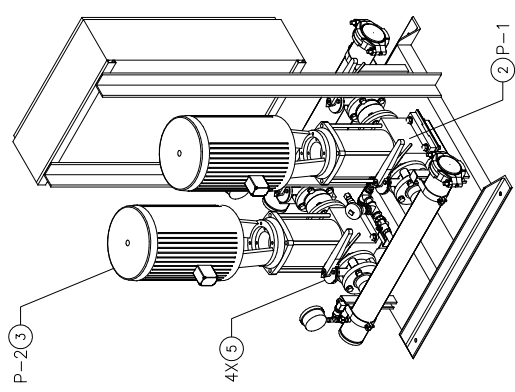
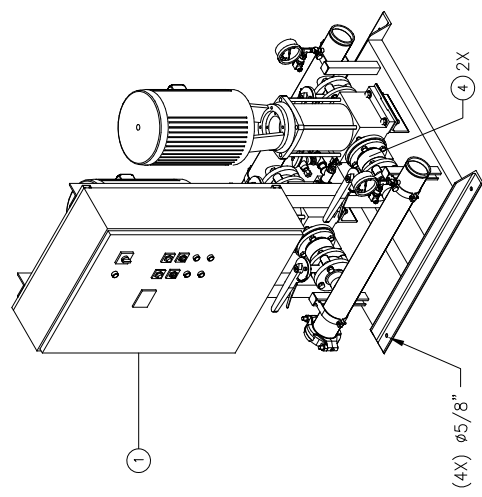


RELIEF VALVES AND
EQUIPMENT DRAINS
TO BE PIPIED TO DRAIN
OR VENT BY CONTRACTOR
PER CODE REQUIREMENT

ALL BOLTING AND ANCHORAGE
TO BE IN COMPLIANCE WITH
LOCAL CODES AND ANY
SEISMIC REQUIREMENTS.

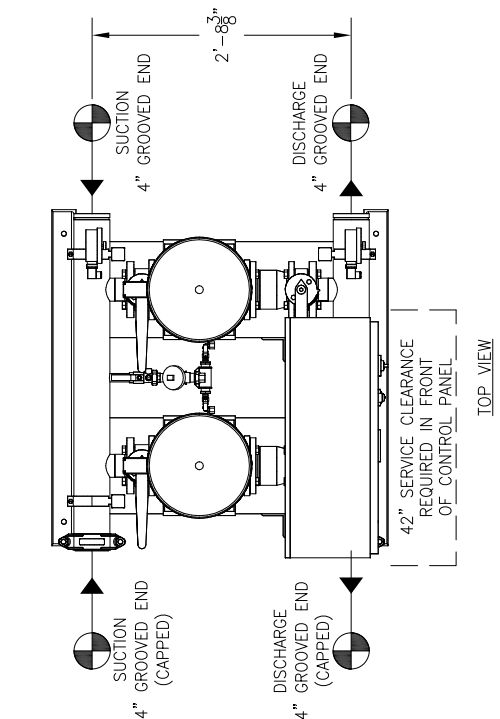

CONSTRUCTION NOTES:
1. SUCTION AND DISCHARGE HEADERS ARE GROOVED ON BOTH ENDS.
2. END CAPS CAN BE PLACED ON EITHER END OF HEADERS.
3. SYSTEM DESIGNED FOR INDOOR INSTALLATION.

- GPM		- PSI		TOTAL DISCHARGE PRESSURE		- PSI		AVAILABLE PRESSURE	
TOTAL FLOW				TOTAL SYSTEM CAPACITY					
3	P-2	GOULDS	ESV	33SVG-4	-	-	20	3500	460 / 60 / 3
2	P-1	GOULDS	ESV	33SVG-4	-	-	20	3500	460 / 60 / 3
ITEM	TAG	MANUFACTURER	SERIES	MODEL	GPM	TDH	HP	RPM	VOLTS/HZ/PH
ENCLOSURE									
PUMP SCHEDULE									
10	-	-	-	-	-	-	-	-	-
9	-	-	-	-	-	-	-	-	-
8	-	-	-	-	-	-	-	-	-
7	-	-	-	-	-	-	-	-	-
6	-	-	-	-	-	-	-	-	-
5	4	-	-	-	-	-	-	-	-
4	2	-	-	-	-	-	-	-	-
3	1	P-2	GOULDS	ESV MULTI-STAGE PUMP MODEL 33SVG-4	-	-	-	-	-
2	1	P-1	GOULDS	ESV MULTI-STAGE PUMP MODEL 33SVG-4	-	-	-	-	-
1	1	-	-	AQUALOGIC XL CONTROL PANEL	-	-	-	-	-
ITEM	QTY	TAG	DESCRIPTION						
EQUIPMENT SCHEDULE									

GENERAL NOTES:
(1) SINGLE POINT POWER CONNECTION AT CONTROL PANEL.
(2) HYDRO PRESSURE CHECK AT 125 PSI.
(3) ASSEMBLED SYSTEM TO BE PAINTED WITH INDUSTRIAL MACHINE ENAMEL PRIOR TO SHIPMENT.

LISTED
PACKAGED PUMPING SYSTEMS
& HEAT TRANSFER SYSTEMS

UL

APPROXIMATE SHIPPING WEIGHT: 1,639 LBS.
APPROXIMATE OPERATING WEIGHT: 1,692 LBS.

PROJECT NAME: -
CUSTOMER: -
DRAWN BY DATE: 04/10/18
CHECKED BY: APPROVED BY: ACD
TOLERANCES UNLESS OTHERWISE SPECIFIED
DEC. .500" FRACTION 1/2" ANGLE 5" SCALE 1" = 1'-0"

FlowTherm
systems
HAYWARD, CALIFORNIA

DRAWING TITLE: FMW2.0-12-XL - VARIABLE SPEED DUPLEX PRESSURE BOOSTER
DRAWING No. FMW2.0-12-XL
FAB No. -
REV 1