
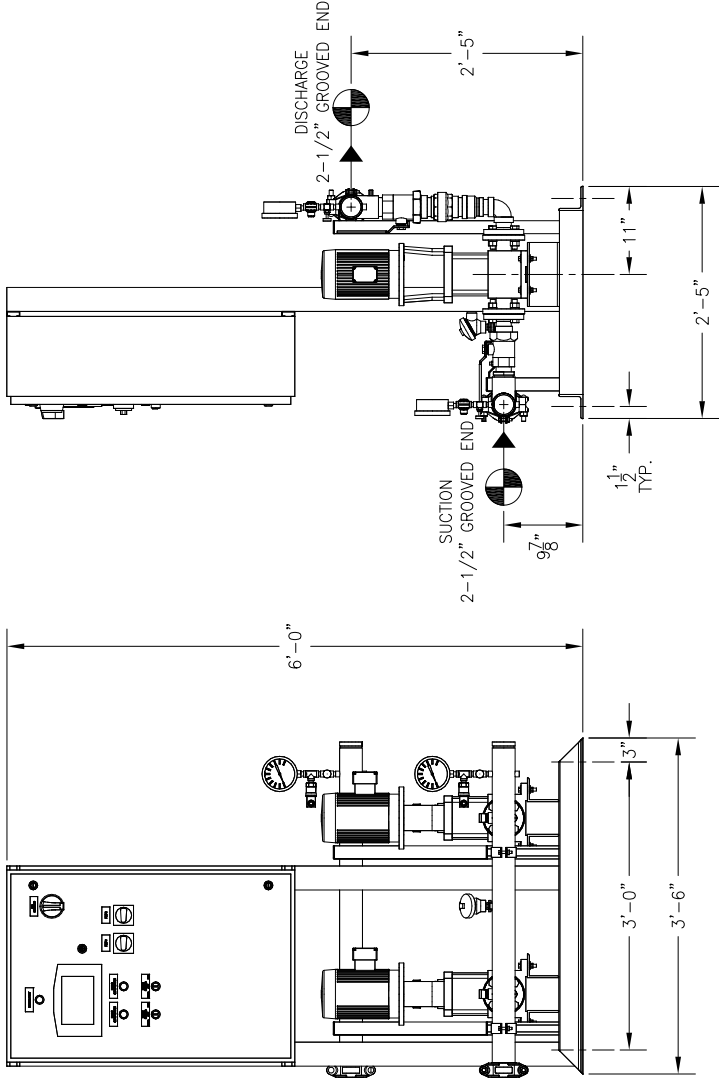
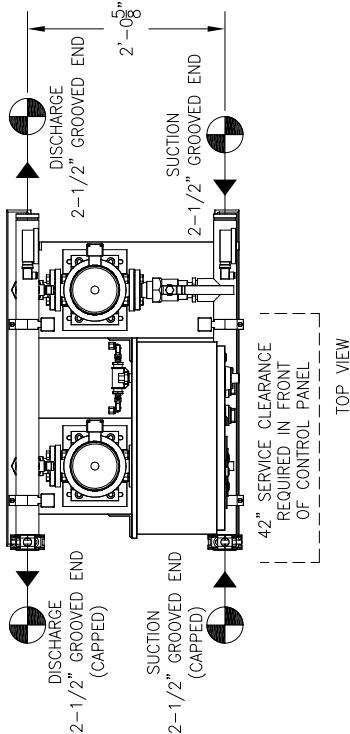


RELIEF VALVES AND
EQUIPMENT DRAINS
TO BE PIPIED TO DRAIN
OR VENT BY CONTRACTOR
PER CODE REQUIREMENTS.

ALL BOLTING AND ANCHORAGE
TO BE IN COMPLIANCE WITH
LOCAL CODES AND ANY
SEISMIC REQUIREMENTS.

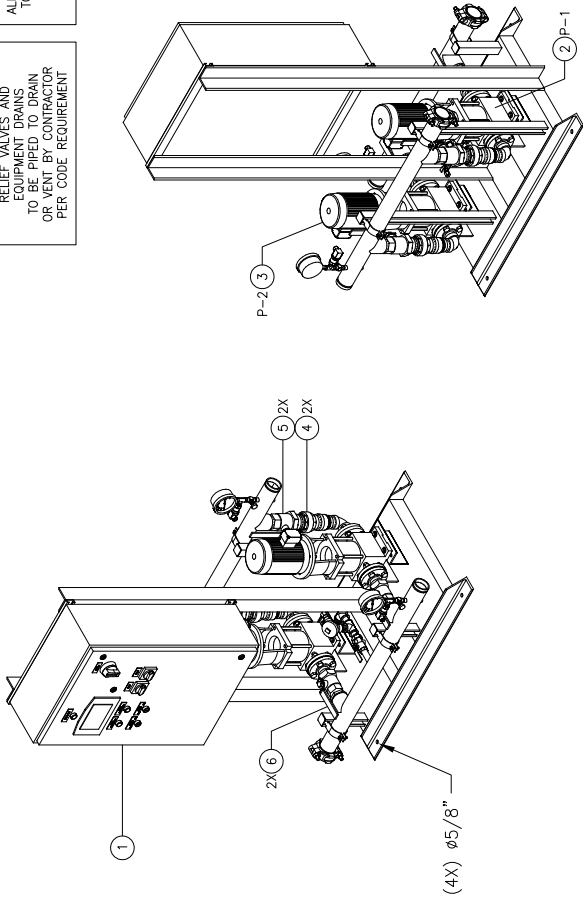

FRONT VIEW


RIGHT END VIEW

- CONSTRUCTION NOTES:
1. SUCTION AND DISCHARGE HEADERS ARE GROOVED ON BOTH ENDS.
 2. END CAPS CAN BE PLACED ON EITHER END OF HEADERS.
 3. SYSTEM DESIGNED FOR INDOOR INSTALLATION.

- GPM		- PSI		- PSI		AVAILABLE PRESSURE				
TOTAL FLOW		TOTAL DISCHARGE PRESSURE		TOTAL SYSTEM CAPACITY						
ITEM	TAG	MANUFACTURER	SERIES	MODEL	GPM	TDH	HP	RPM	VOLTS/42/PH	ENCLOSURE
3	P-2	GOULDS	ESV	5SVG-5	-	-	1 1/2	3500	460 / 60 / 3	TEFC P.E.
2	P-1	GOULDS	ESV	5SVG-5	-	-	1 1/2	3500	460 / 60 / 3	TEFC P.E.
PUMP SCHEDULE										
10	-	-	-	-	-	-	-	-	-	-
9	-	-	-	-	-	-	-	-	-	-
8	-	-	-	-	-	-	-	-	-	-
7	-	-	-	-	-	-	-	-	-	-
6	2	-	-	-	-	-	-	-	-	-
5	2	-	-	-	-	-	-	-	-	-
4	2	-	-	-	-	-	-	-	-	-
3	1	P-2	GOULDS	ESV MULTI-STAGE PUMP	MODEL 5SVG-5	-	-	-	-	-
2	1	P-1	GOULDS	ESV MULTI-STAGE PUMP	MODEL 5SVG-5	-	-	-	-	-
1	1	-	-	-	-	-	-	-	-	-
EQUIPMENT SCHEDULE										
ITEM	QTY	TAG	DESCRIPTION							

- GENERAL NOTES:
- (1) SINGLE POINT POWER CONNECTION AT CONTROL PANEL.
 - (2) HYDRO PRESSURE CHECK AT 125 PSI.
 - (3) ASSEMBLED SYSTEM TO BE PAINTED WITH INDUSTRIAL MACHINE ENAMEL PRIOR TO SHIPMENT.

 = DENOTES CONTRACTOR POINT OF CONNECTION



PACKAGED PUMPING SYSTEMS
& HEAT TRANSFER SYSTEMS

APPROXIMATE SHIPPING WEIGHT: 660 LBS.
APPROXIMATE OPERATING WEIGHT: 730 LBS.

PROJECT NAME:
CUSTOMER:

DRAWN BY DATE: 09/10/19
ACD

TOLERANCES UNLESS OTHERWISE SPECIFIED
DEC. .500" FRACTION 1/2" ANGLE 5" SCALE 1" = 1'-0"

DRAWING TITLE:
FAB No. DRAWING No. REV



HAYWARD, CALIFORNIA

FWM2.1-1-XL - VARIABLE SPEED DUPLEX PRESSURE BOOSTER

REV 1